


1 WOOD PLATFORM BENCH


1:20

P-GLM-FUR-08


- NOTES:
- PROVIDE SHOP DRAWINGS FOR REVIEW PRIOR TOP FABRICATION, SEE SPECIFICATION
 - SHOPS DRAWINGS FOR WORK TO INCLUDE SEAL OF QUALIFIED PROFESSIONAL ENGINEER, SEE SPECIFICATION

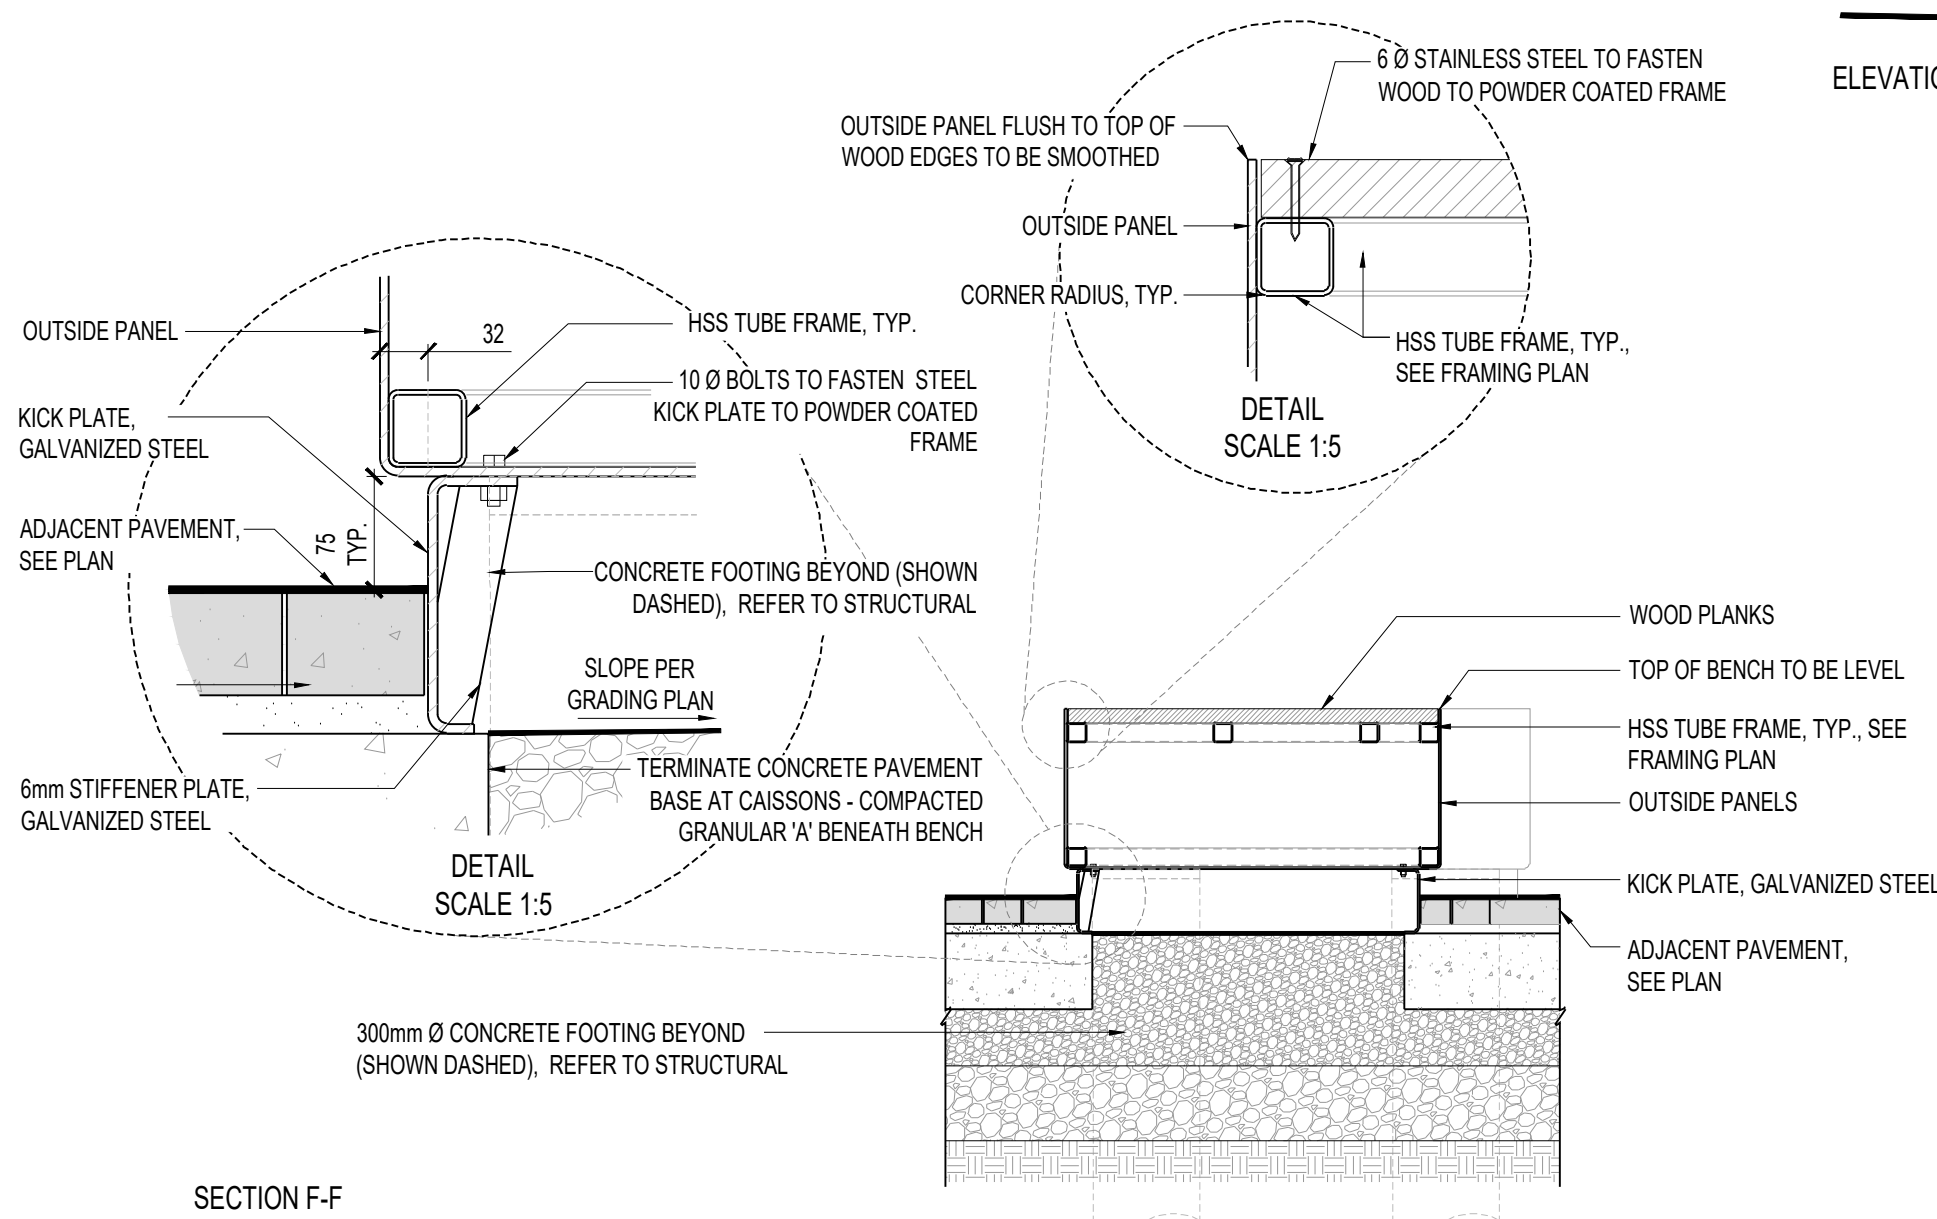


SECTION F-F

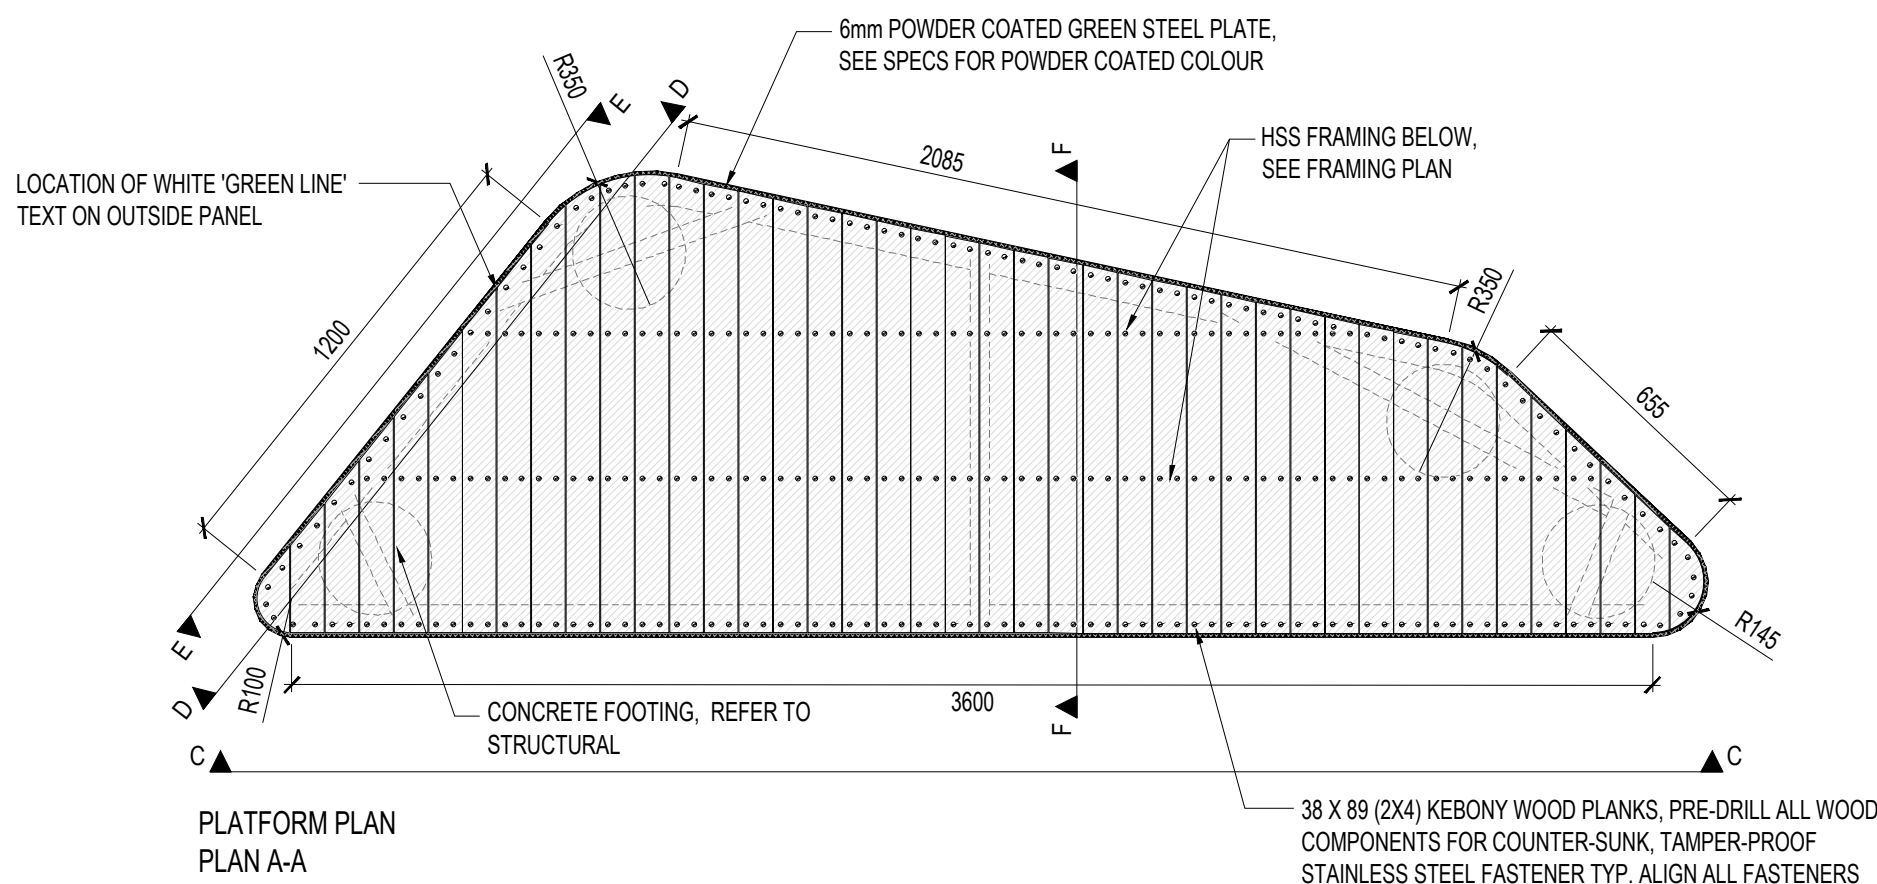


PLATFORM PLAN
PLAN A-A

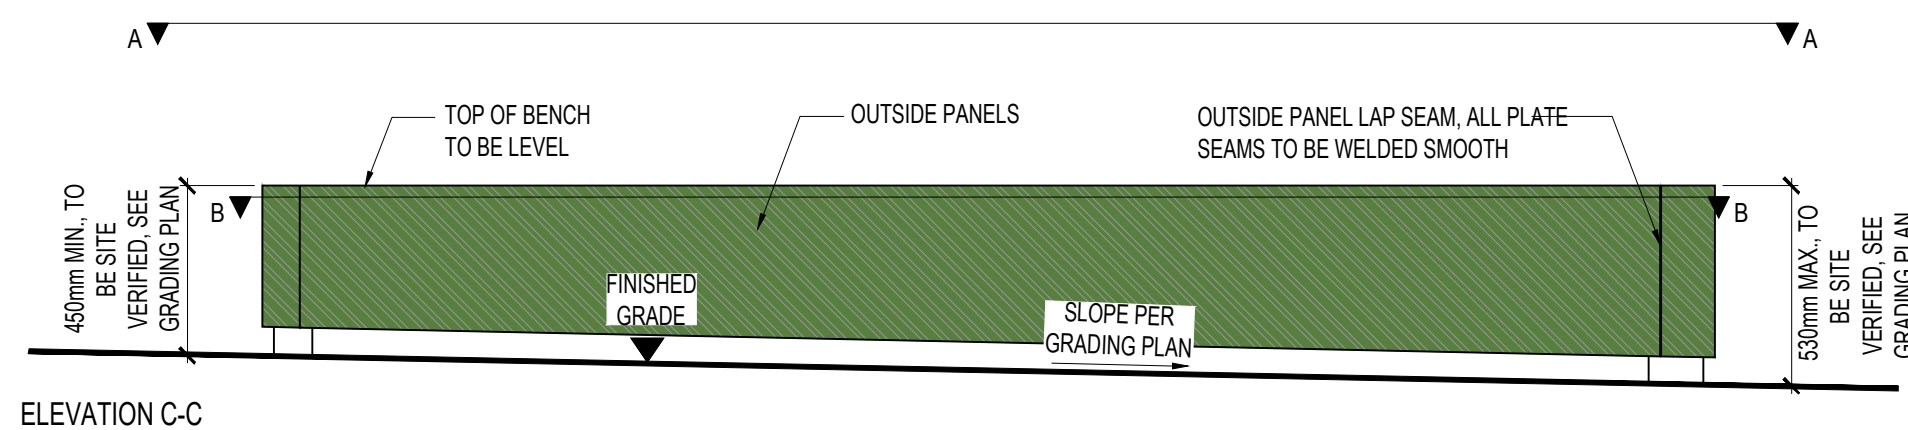


ELEVATION C-C

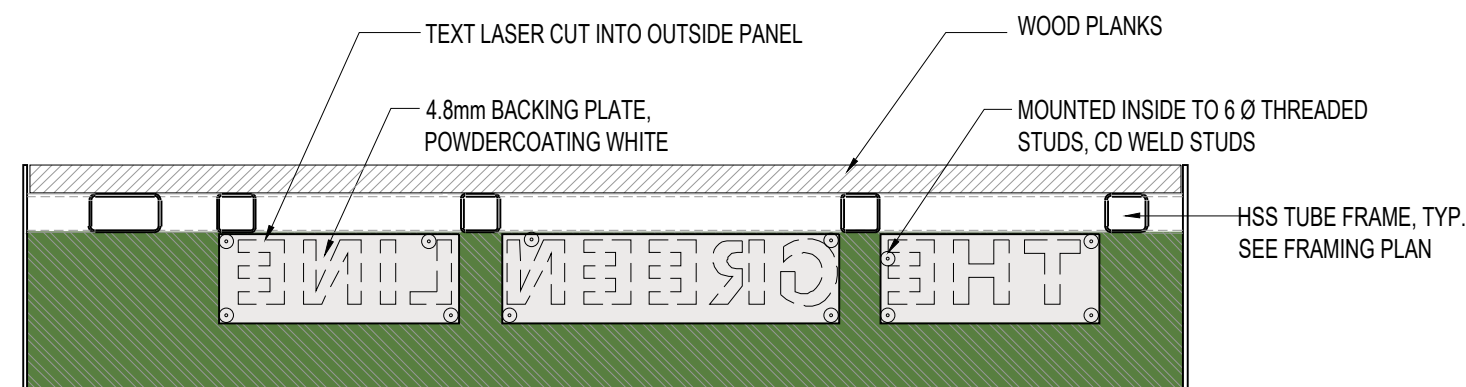

SECTION D-D
SCALE 1:10

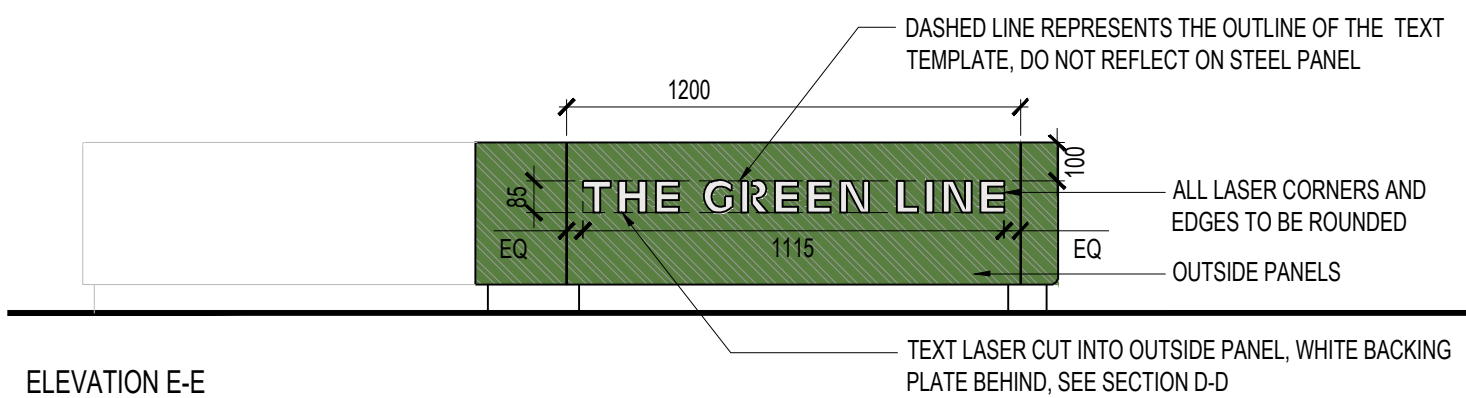

ELEVATION E-E

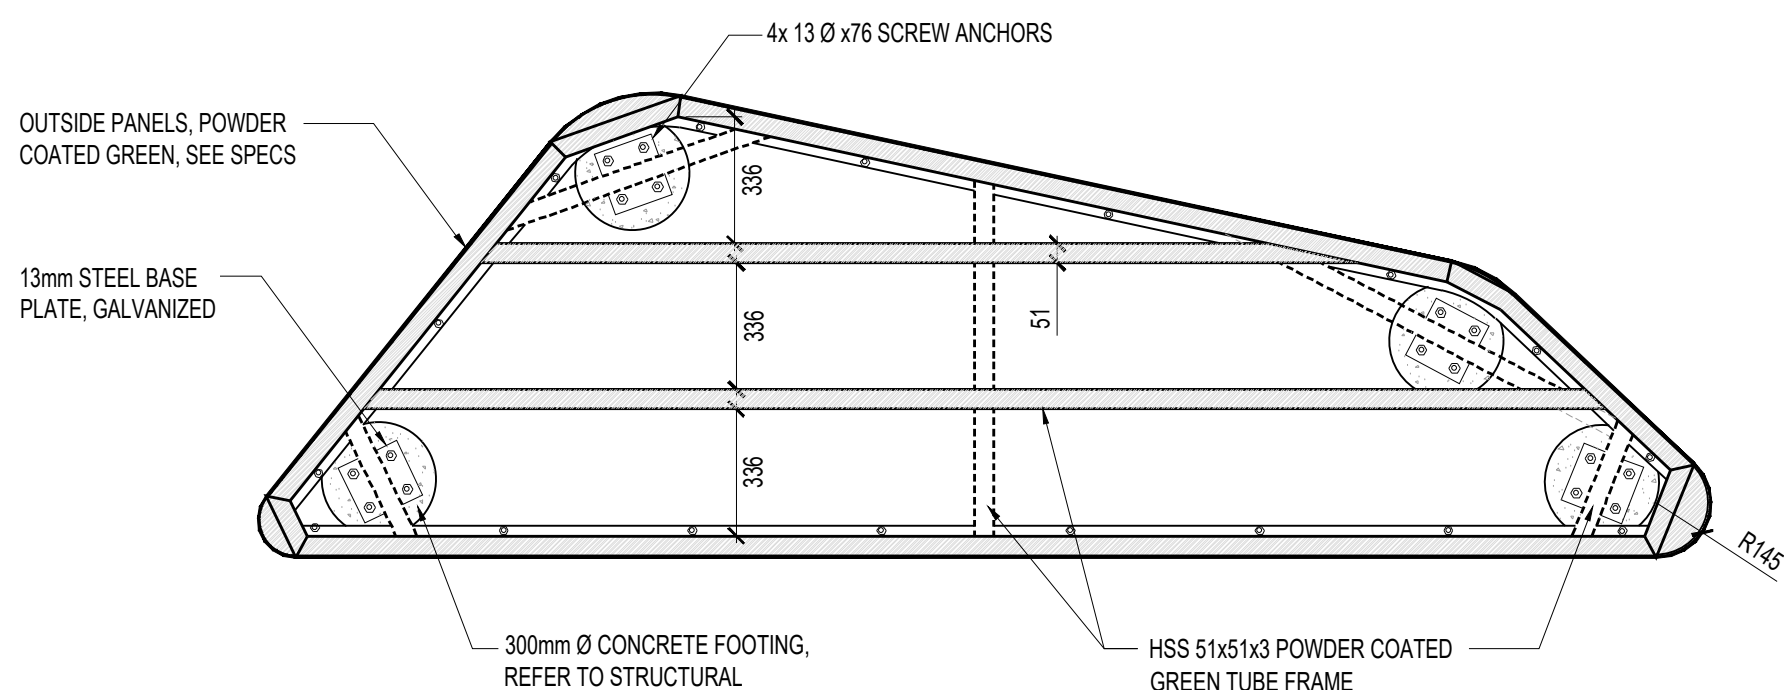

FRAMING PLAN
PLAN B-B

NOTES:

REFER TO CAPPING PLAN BY WSP FOR CAPPING DEPTH BELOW SOFTSCAPE AND HARDSCAPE ELEMENTS

NOTES:

REFER TO ELECTRICAL PLANS BY DPM FOR GROUNDING INFORMATION.

NO.	DATE	DESCRIPTION
12.	2026-04-02	TENDER ADDENDUM 01
11.	2026-02-20	RE-ISSUED FOR TENDER
10.	2025-05-12	RE-ISSUED FOR TENDER
9.	2024-11-15	RE-ISSUED FOR HONI REVIEW
8.	2024-09-16	ISSUED FOR HONI REVIEW
7.	2022-09-01	ISSUED FOR TENDER
6.	2022-03-28	ISSUED FOR 95% REVIEW
5.	2022-03-23	ISSUED FOR HONI REVIEW
4.	2022-02-16	ISSUED FOR 50% REVIEW
ISSUE RECORD		

THE CONTRACTOR SHALL VERIFY AND BE RESPONSIBLE FOR ALL DIMENSIONS AND CONDITIONS ON THE JOB SITE AND SHALL INFORM THE LANDSCAPE ARCHITECTS IMMEDIATELY OF ANY DISCREPANCY OR VARIATION FROM THE DRAWINGS. DO NOT SCALE THE DRAWINGS. DRAWINGS ARE NOT TO BE USED FOR CONSTRUCTION UNTIL SIGNED BY THE LANDSCAPE ARCHITECT. ALL DRAWINGS, SPECIFICATIONS AND RELATED DOCUMENTS ARE THE COPYRIGHT PROPERTY OF THE LANDSCAPE ARCHITECT AND MUST BE RETURNED UPON REQUEST. REPRODUCTION OF DRAWINGS, SPECIFICATIONS AND RELATED DOCUMENTS IN PART OR IN WHOLE IS FORBIDDEN WITHOUT WRITTEN PERMISSION.

dtah
425 Adelaide St. W
Suite 600
Toronto, Ontario
M5V 3C1
T 416 968 7908
www.dtah.com

**GREEN LINE
PARK ON
MACPHERSON AVE**
TORONTO, ONTARIO

DRAWING TITLE:

**WOOD PLATFORM
BENCH DETAILS**

PRINT DATE: April 1, 2026
SCALE:
PROJECT NO. 20-004
DRAWN BY: SCB
CHECKED BY: SL

L-705